
 
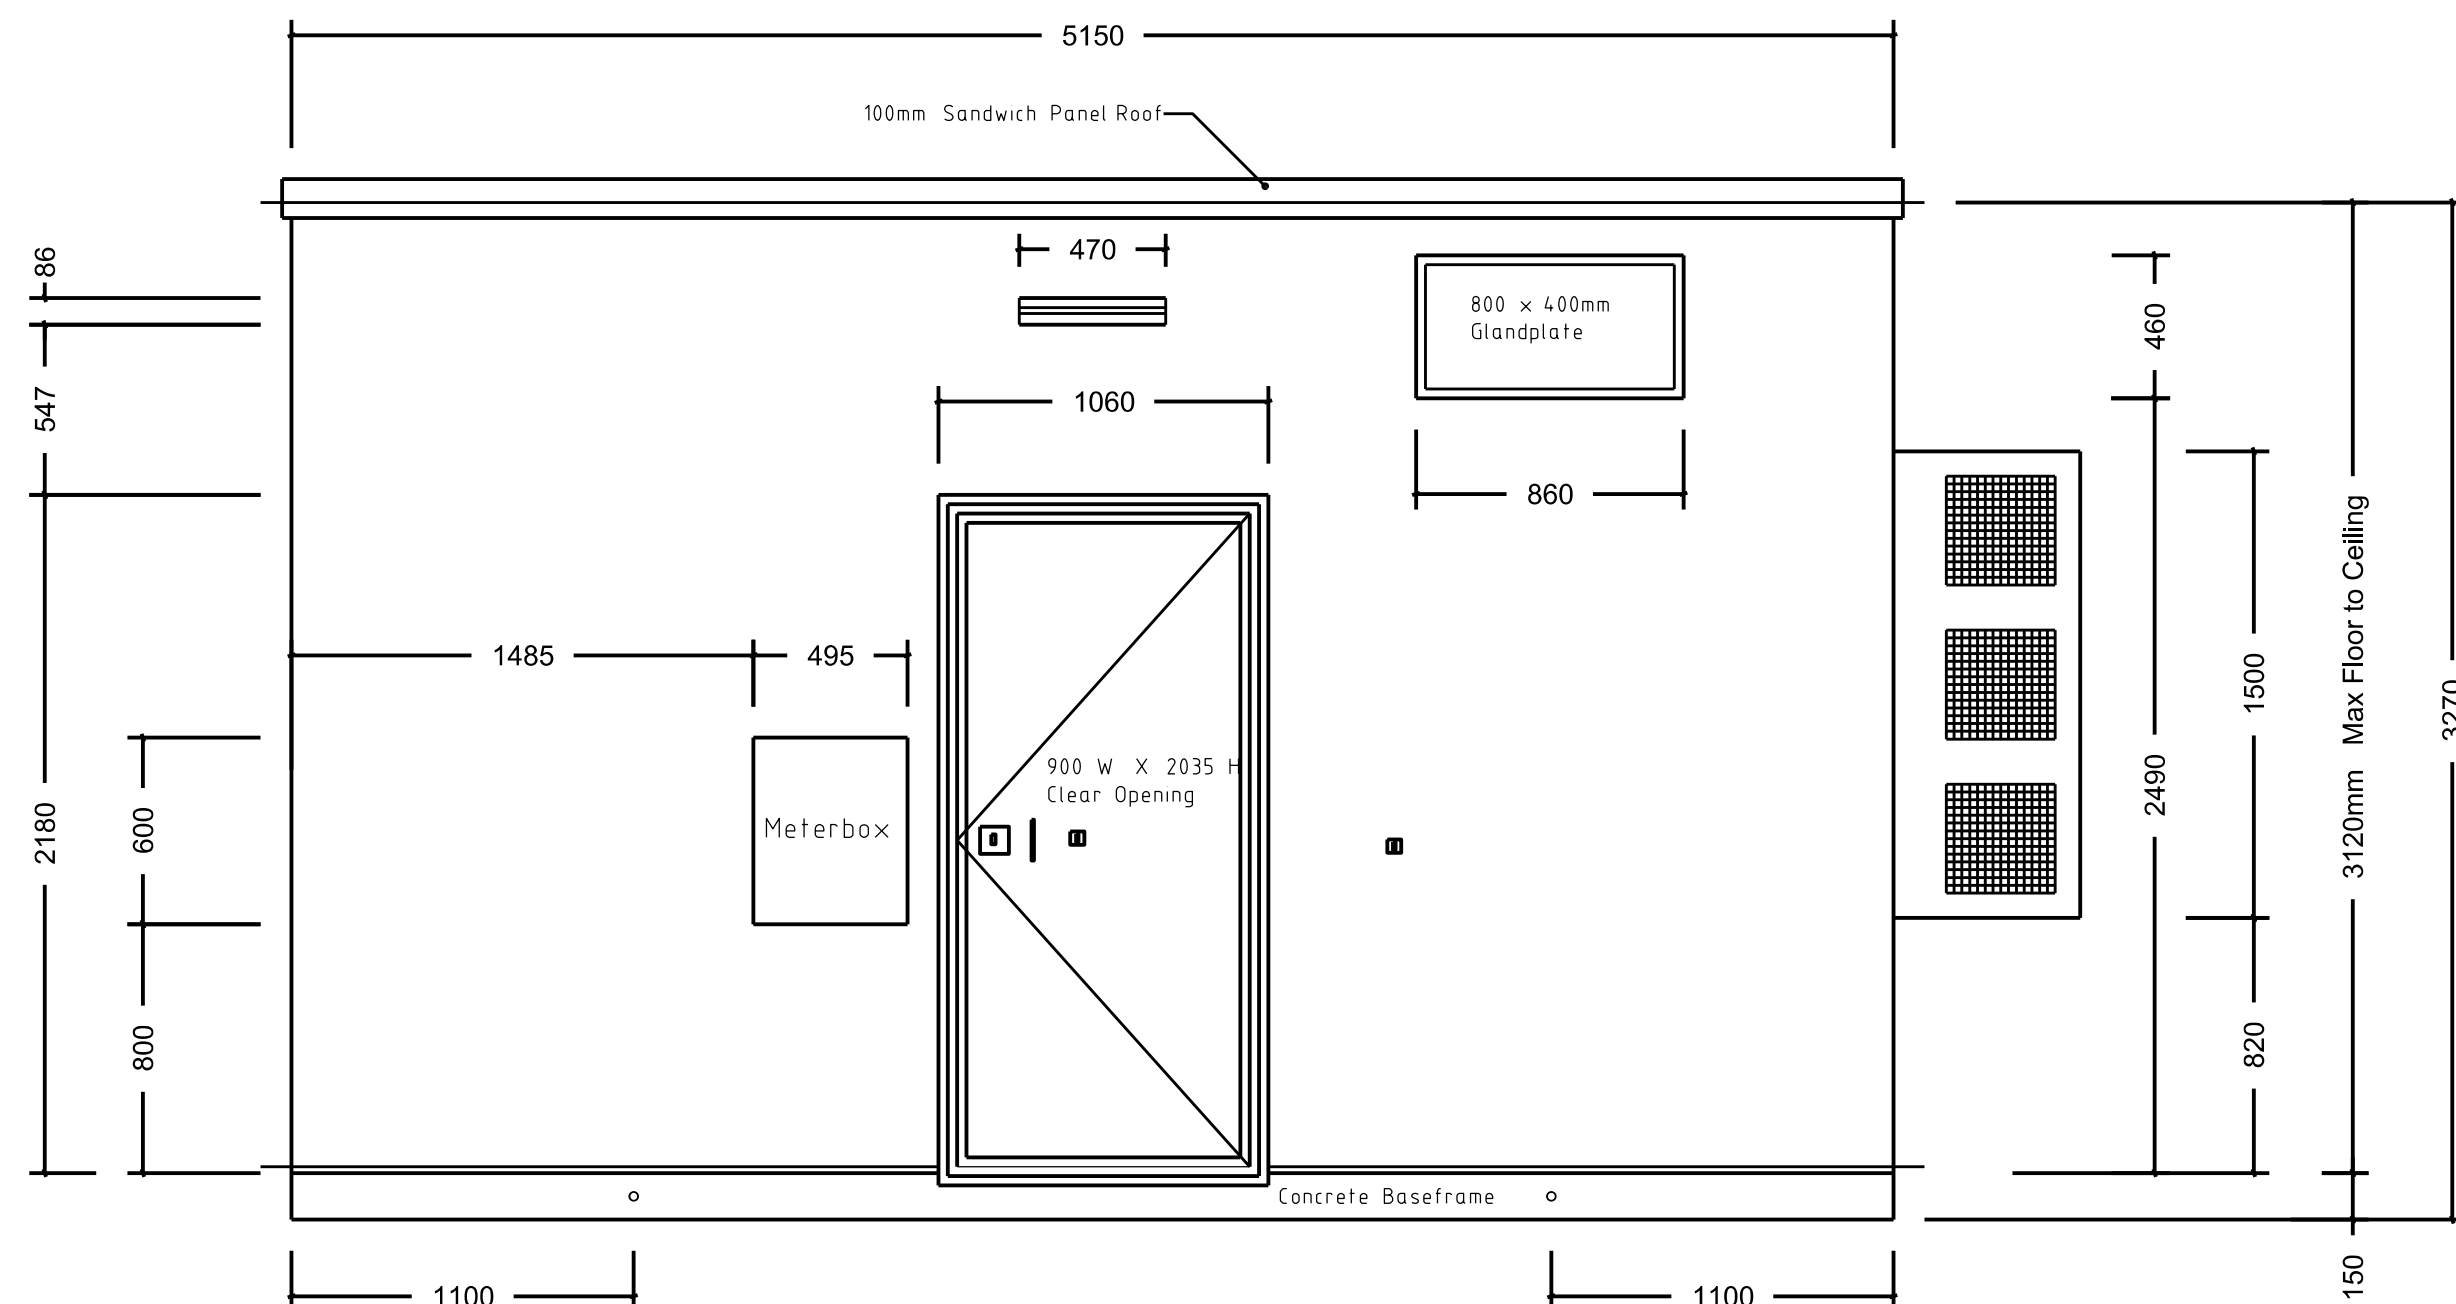



TOLERANCES UNLESS OTHERWISE
SPECIFIED REFER DRAWING:




ELEVATION A
SCALE: Not To Scale

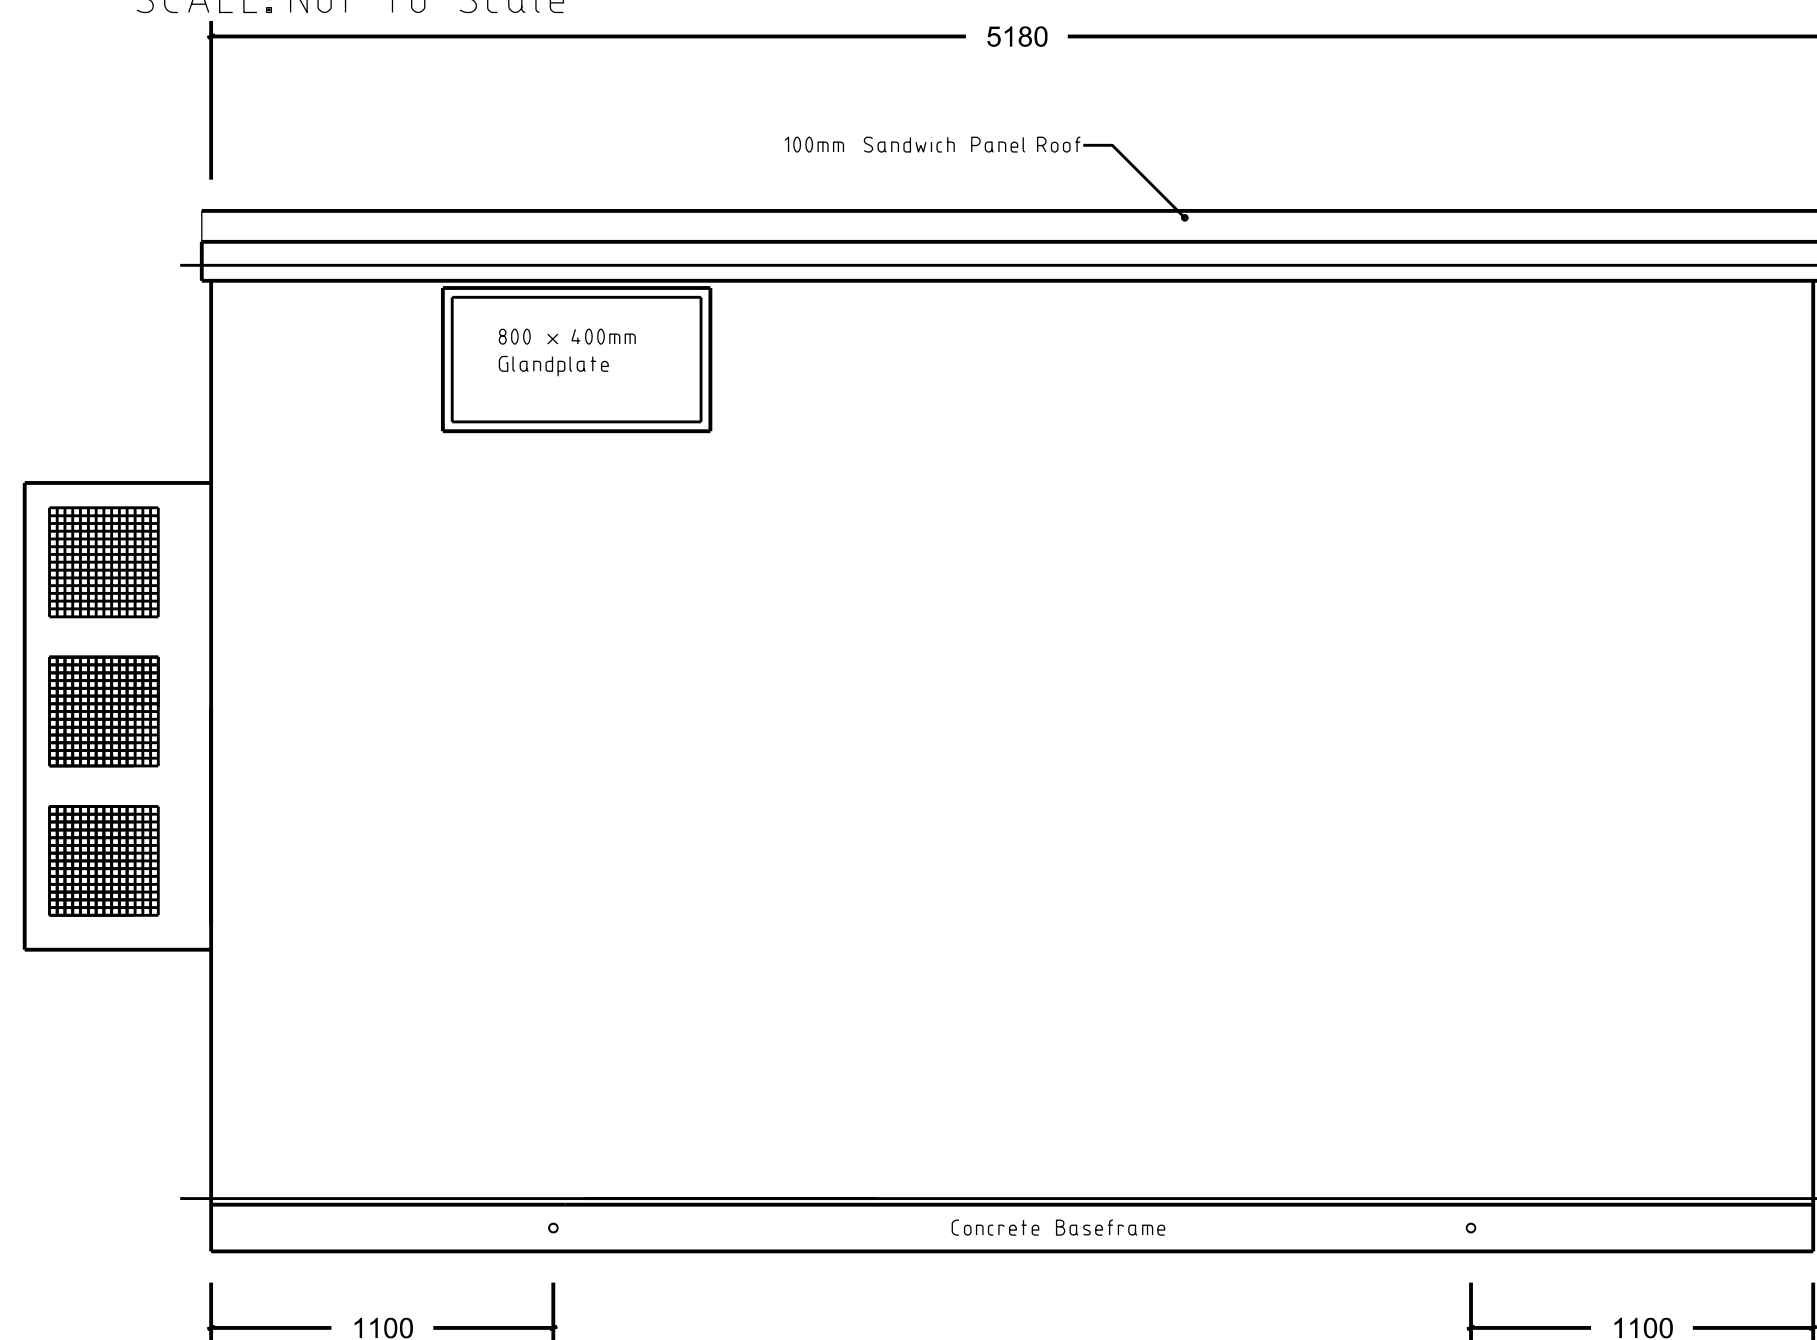

ELEVATION C
SCALE: Not To Scale

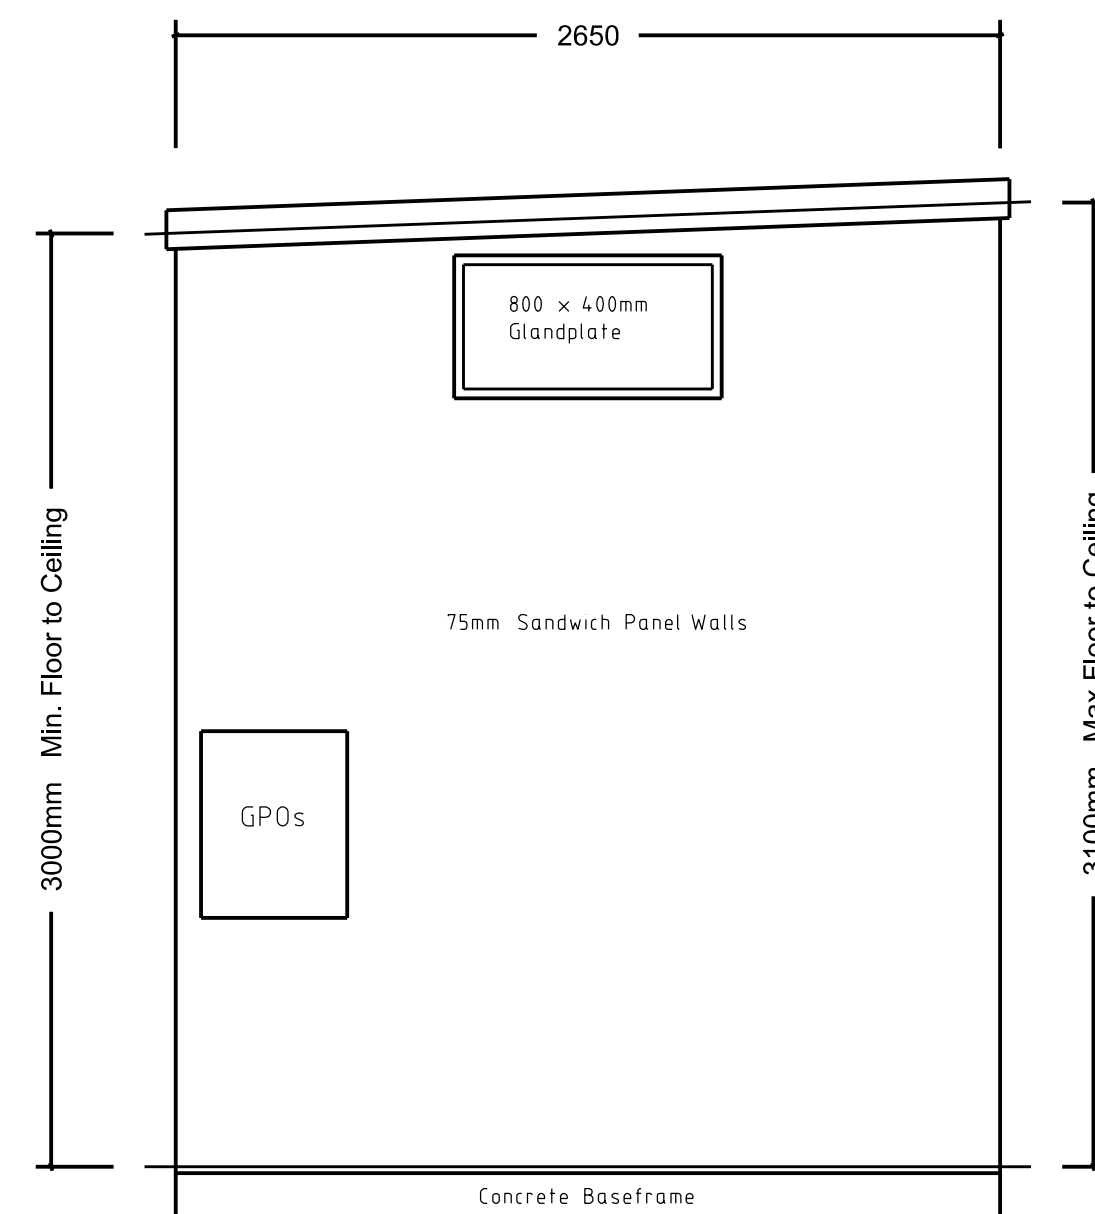

ELEVATION B
SCALE: Not To Scale

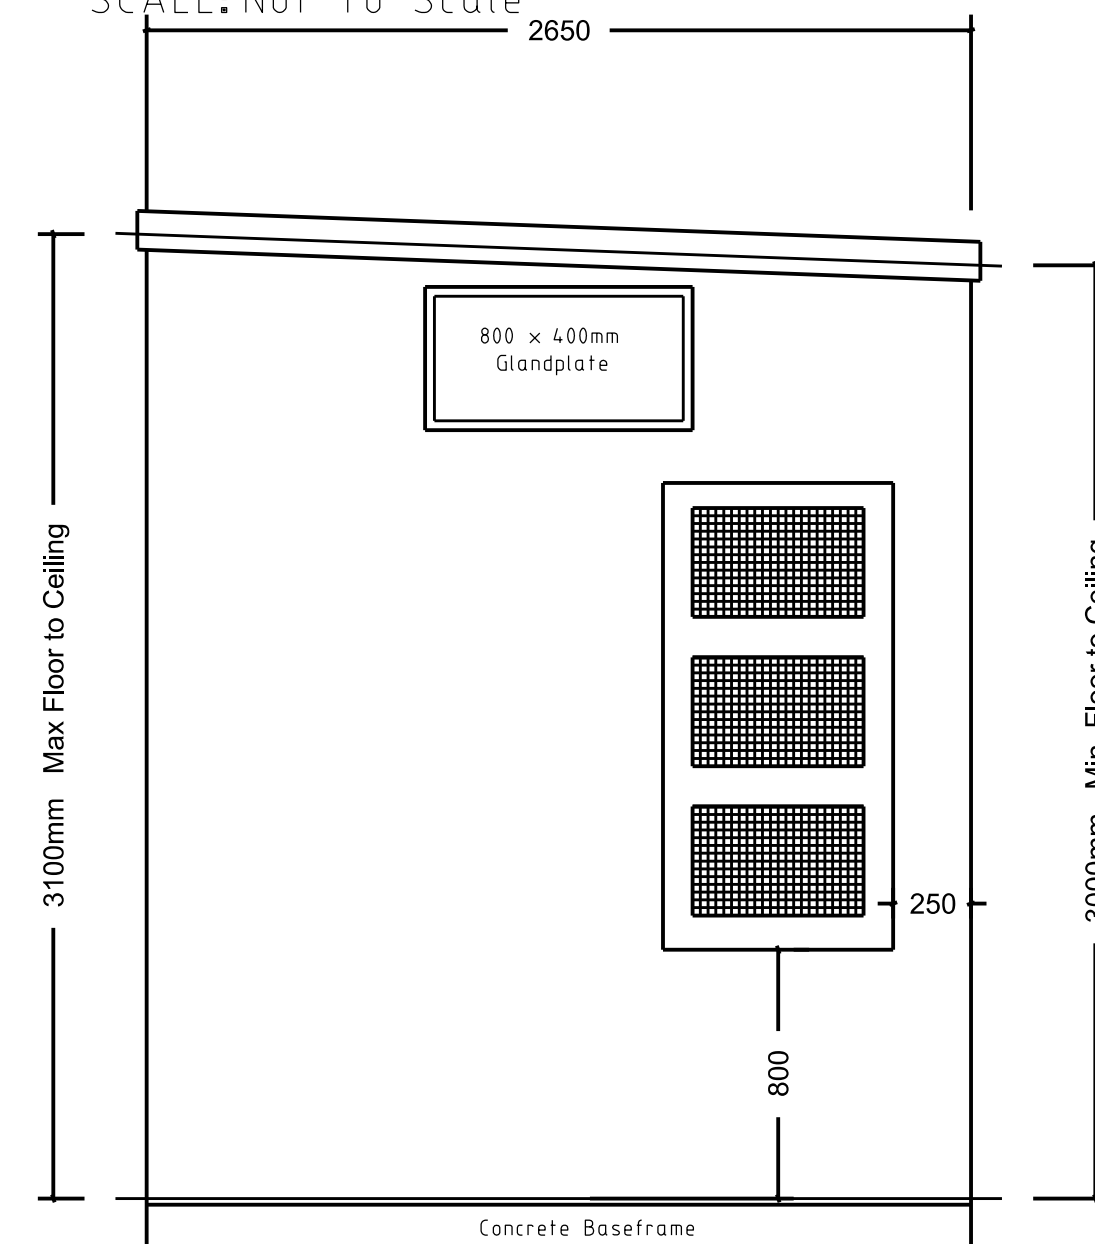

ELEVATION D
SCALE: Not To Scale

NOTES:

AT A COMMUNICATIONS SITE THIS DRAWING
BECOMES: 319 SSD/029-XXX

FOR COMMUNICATIONS BUILDING REFER: 410 SSD/301-041

FOR ELECTRICAL PLAN REFER: 410 SSD/303-041

FOR SECURITY AND FIRE REFER: 410 SSD/303-042

ElectraNet
ISSUED FOR INFORMATION
28/06/2011 & REV A,3
PROJECT #11041
SIGNED G.SCHERSTOBIT

REV	DETAILS OF REVISION	RVD	CKD	APD	DATE
A	11041 FIRST ISSUE ENET	TJM	MJE	DS	06/11

© ElectraNet
THIS DRAWING IS TO BE USED FOR THE PURPOSES IT HAS BEEN PROVIDED BY THE PERSON TO WHOM IT HAS BEEN PROVIDED, NEITHER THE DRAWING NOR ANY PART OF IT CAN BE REPRODUCED, COPIED OR ALTERED, WITHOUT THE CONSENT OF ElectraNet. ALL INFORMATION CONTAINED WITHIN THE DRAWING IS CONFIDENTIAL TO ElectraNet AND MUST NOT BE DISCLOSED TO A THIRD PARTY WITHOUT THE PRIOR CONSENT OF ElectraNet.

THIS TEMPLATE DRAWING IS A DESIGN TOOL
TO BE MODIFIED TO SUIT INDIVIDUAL PROJECTS.
ALL TEXTS SHOWN AS &TEXT& ARE GENERIC EXAMPLES

CREATED FROM TEMPLATE;	REV	SUB TITLE	+&BLD& COMMUNICATIONS BUILDING PLAN AND ELEVATION			
DRAWING WAS PREVIOUSLY;	REV					
DRN	T.MARGITICH	06/11	ElectraNet - electricity transmission			
CKD	M.ELDRIDGE	06/11	CONTROL BUILDING - ARCHITECTURAL &SUBNAME& SUBSTATION			
INSP	G.SCHERSTOBIT	06/11				
AUTH	D.SCHUTZ	06/11	SCALE	N.T.S.	A1 410 SSD/691-041	REV A DISTB