


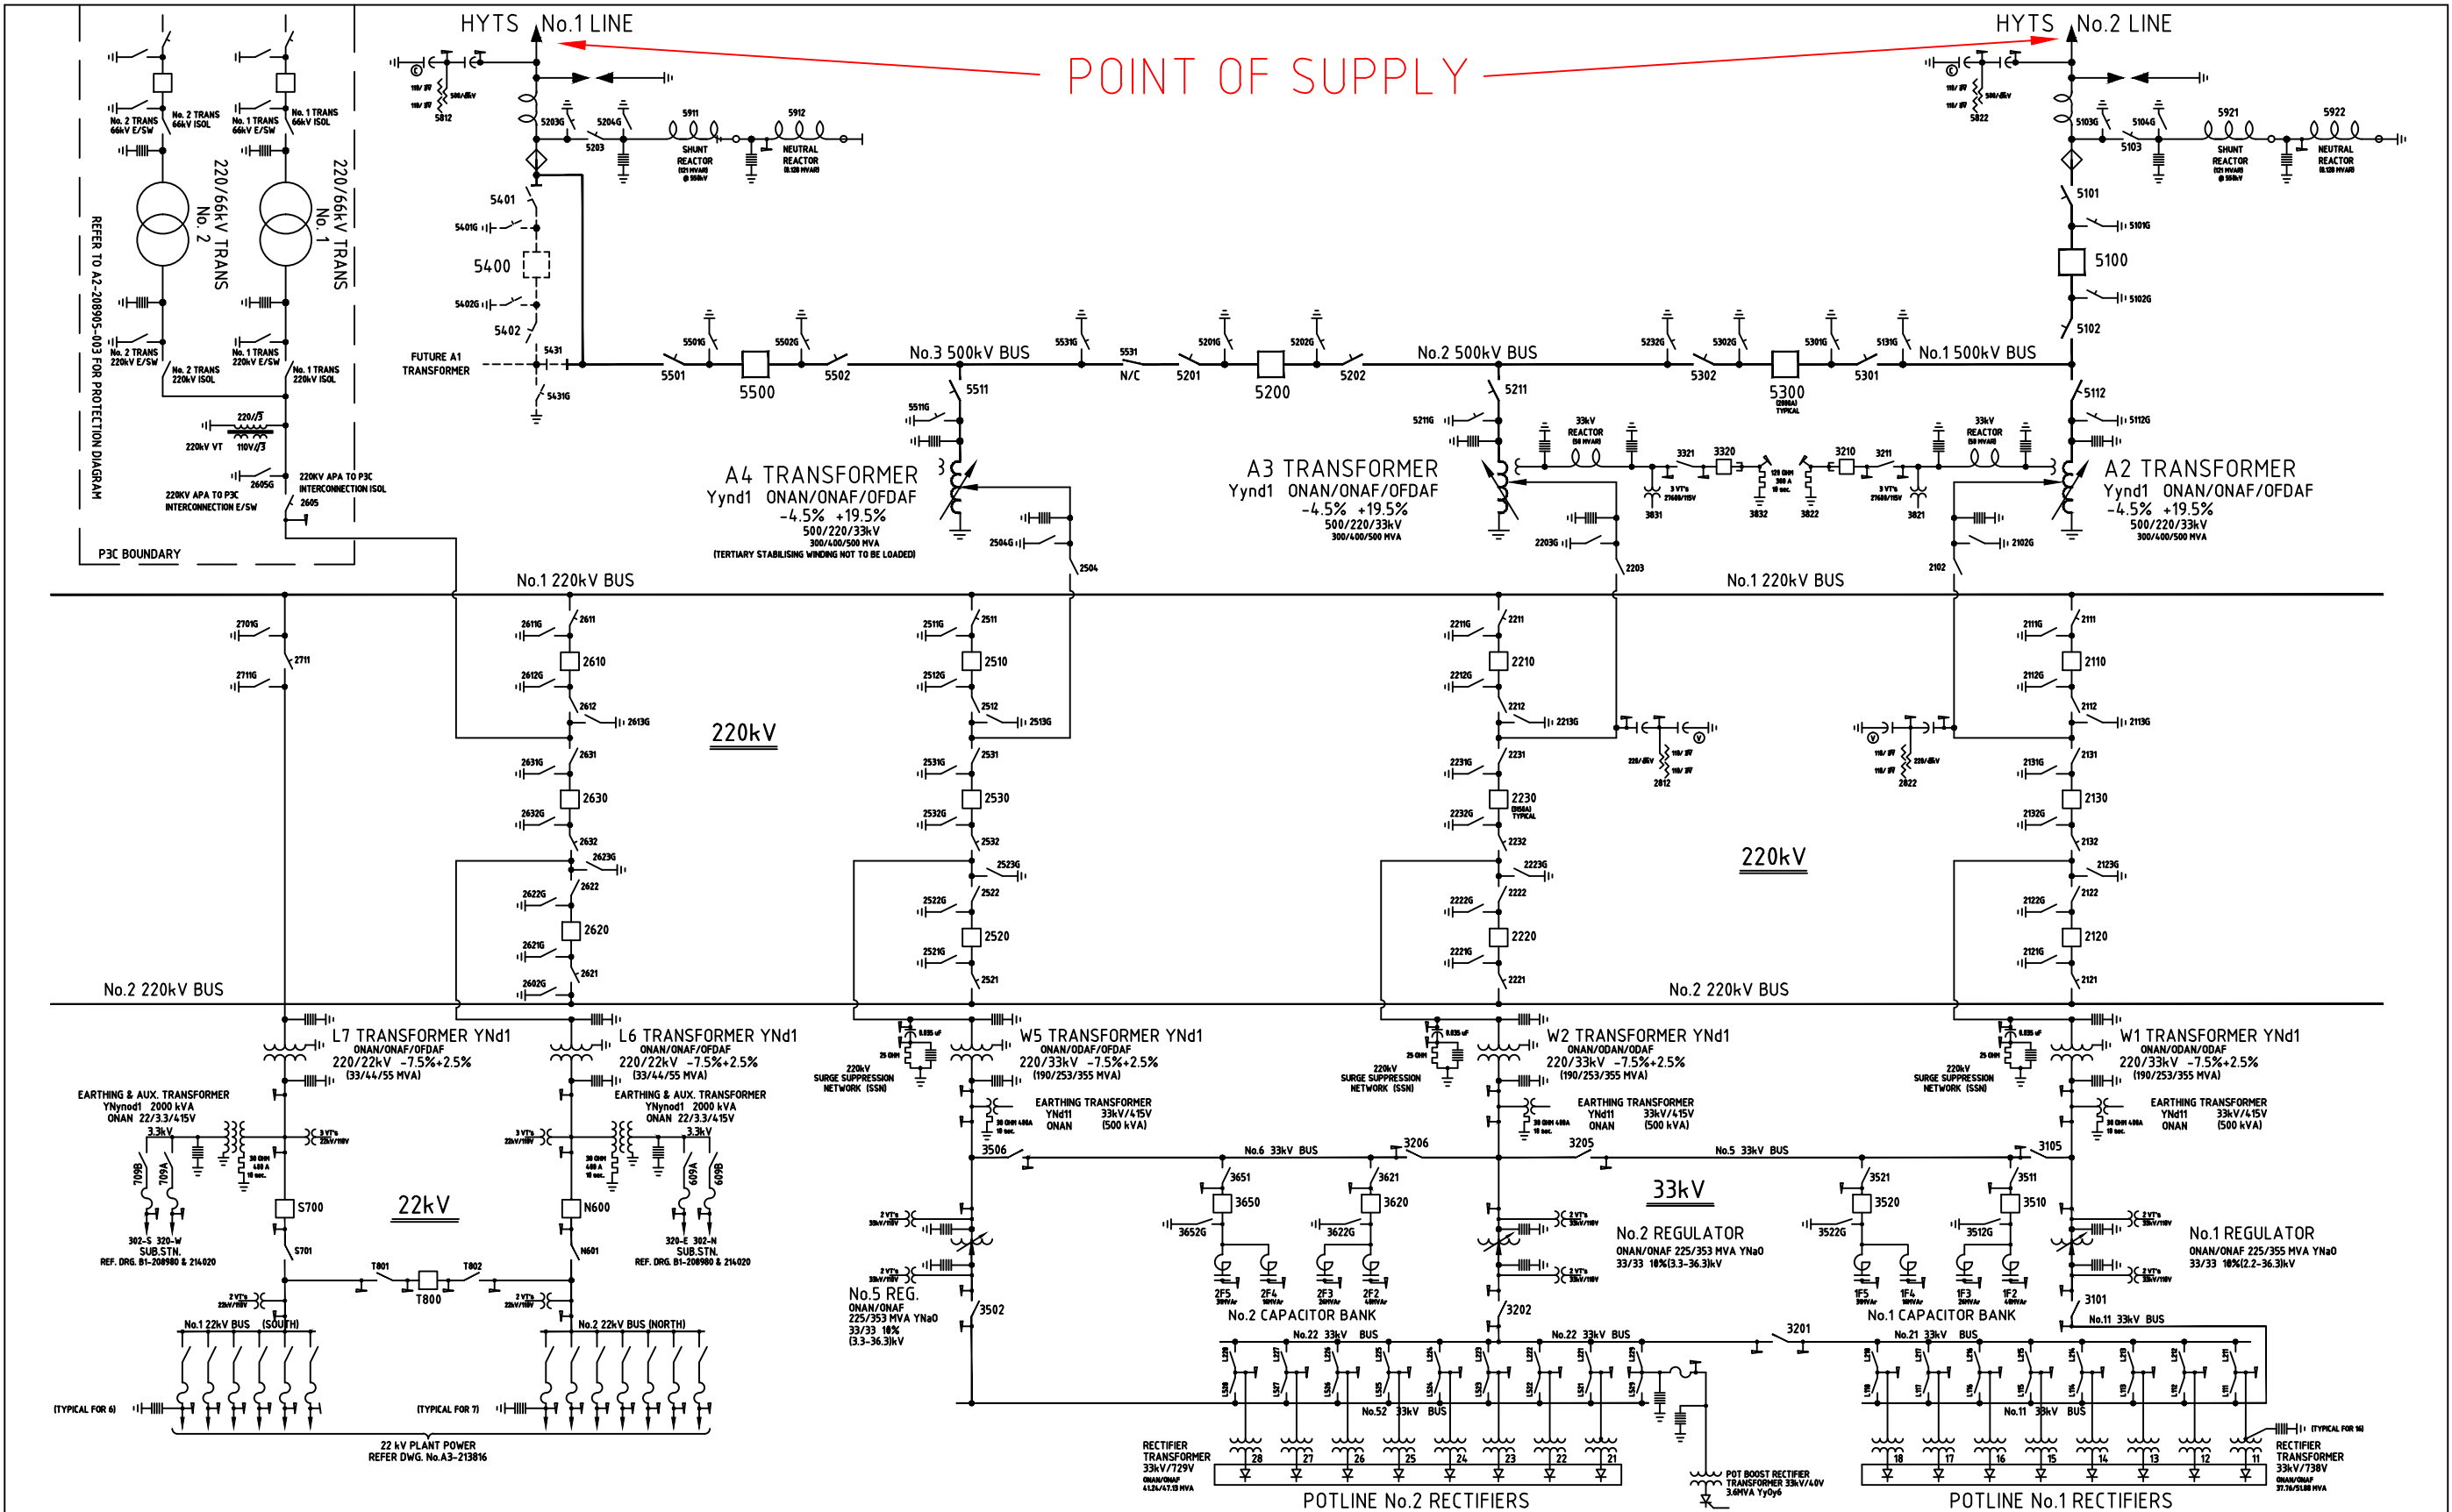

GENERAL NOTES		CAUTION: THIS IS A CADD GENERATED DRAWING AND ANY CHANGES TO IT MUST BE DONE ON COMPUTER. CADD FILE NAME: FILENAME		97 FEB 28		POTLINE No.2 RECTIFIERS		PORTLAND SMELTER SERVICES PTY. LTD. (Incorporated in Victoria)	
B1-208980 SUB-STATION 320T SINGLE LINE DIAGRAM		SIGNED		95 OCT 18		POTLINE No.1 RECTIFIERS		PORTLAND ALUMINIUM	
B1-214020 SUB-STATION 320T SINGLE LINE DIAGRAM		NOTE: FOR FURTHER DETAIL ON RECTIFIER STATION & POTLINE SEE DWG.B1-031800-PV		95 FEB 21		POTLINE No.2 RECTIFIERS		SWITCHING DIAGRAM	
B1-208902 500/220kV SWITCHYARD CT. ARRANGEMENT		GENERAL NOTES		95 FEB 8		POTLINE No.1 RECTIFIERS		ENGINEER: D LEEK	
B1-208904 500/220kV PROTECTION RELAY FUNCTION DIAGRAM		REVISION RECORD		94 DEC 12		POTLINE No.2 RECTIFIERS		PLANT CODE: PV	
B1-208905 220kV PROTECTION RELAY FUNCTION DIAGRAM		08 JAN 17 29 ADD PC3 YARD & BAY 4 SWITCHGEAR		93 SEP 21		POTLINE No.1 RECTIFIERS		DWG CLASS	
B1-208906 33kV PROTECTION RELAY FUNCTION DIAGRAM		07 OCT 29 28 REVISE POT BOOST XFMR & REMOVE L/BREAKER		93 SEP 21		POTLINE No.2 RECTIFIERS		DRAWN BY: E. GALUSHKIN	
REF: B1-208907 KEY-ENCLOSURE RELAY FUNCTION DIAGRAM		05 AUG 26 27 REVISE RECT. XFMR RATING		93 SEP 21		POTLINE No.1 RECTIFIERS		CHECKED BY:	
DRG NO		REFERENCE DRAWINGS		99 APR 06 24 REMOVE POTBOOST SPECIFIC TEXT & RENUMBER		POTLINE No.2 RECTIFIERS		APPROVED	